

SAFETY, HEALTH AND ENVIRONMENTAL INFORMATION
--

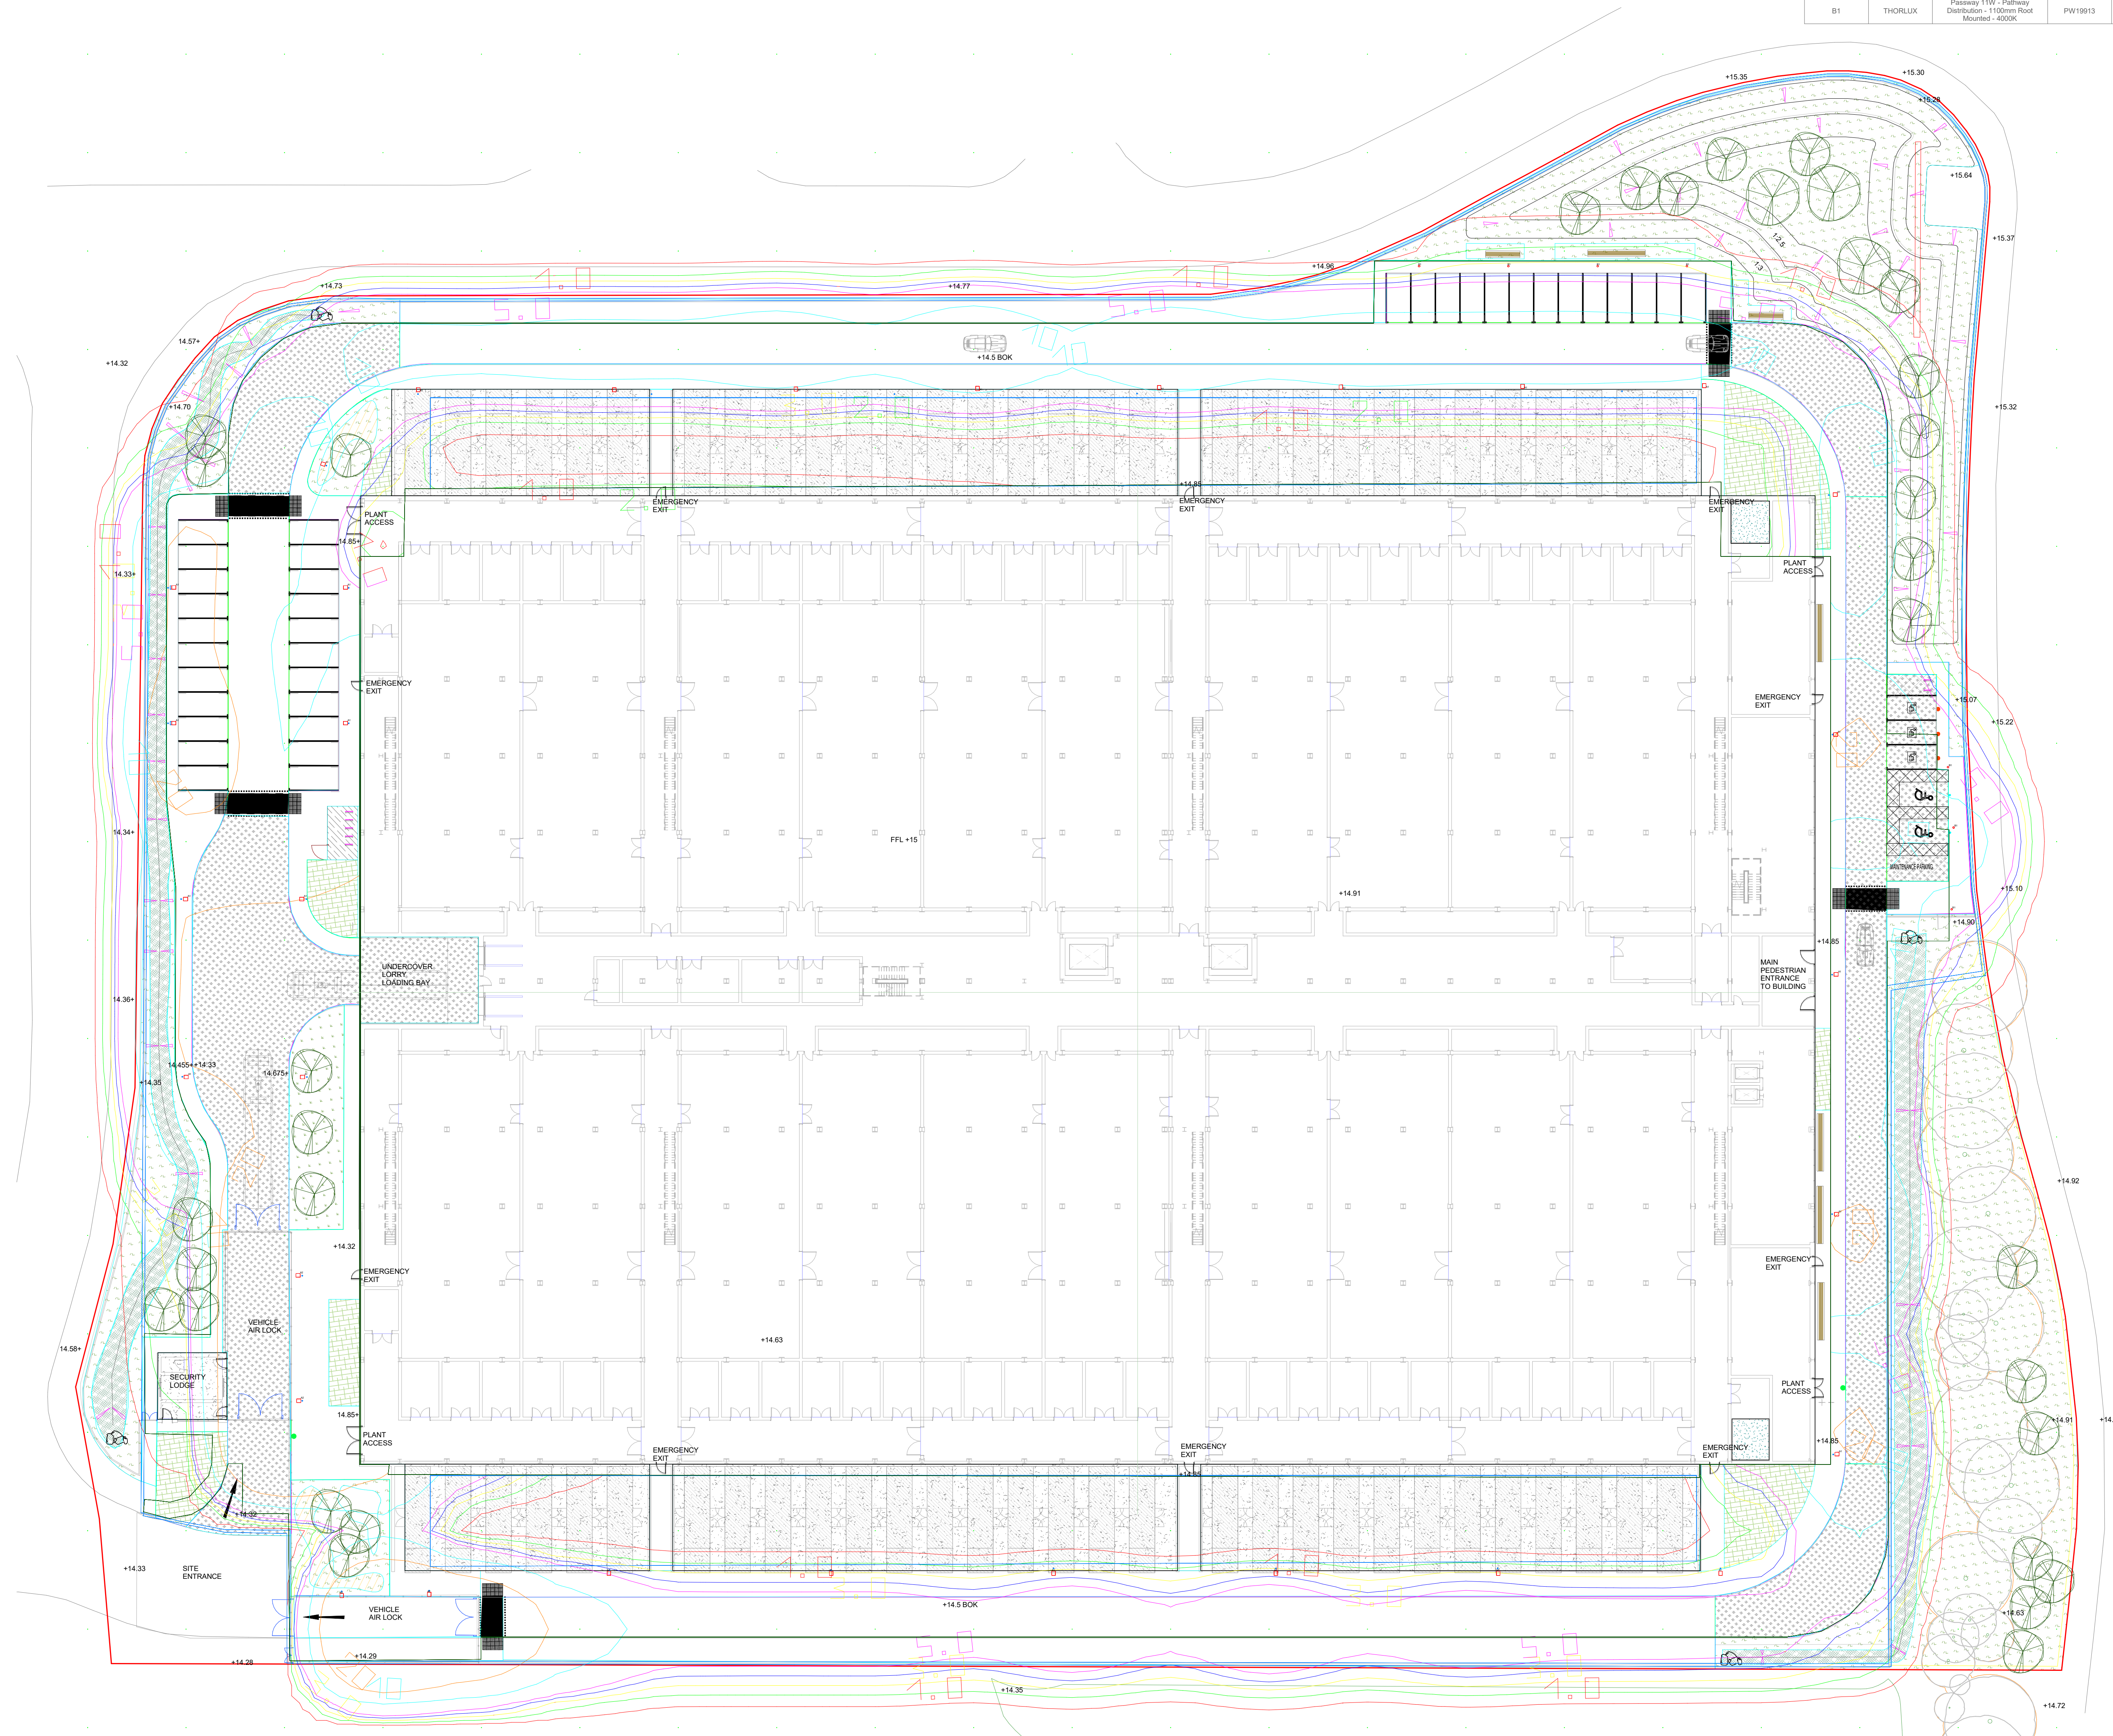
## CONSTRUCTION

DECOMMISSIONING/DEMOLITION	
----------------------------	--

**Legend**

- 1lx — — — — —  
2lx — — — — —  
3lx — — — — —  
4lx — — — — —  
5lx — — — — —  
10lx — — — — —  
20lx — — — — —

Luminaire list (Site 1)								
Index	Manufacturer	Article name	Item number	Fitting	Luminous flux	Maintenance factor	Connected load	Quantity
A1	Thorlux	STARBEAM LED ROADWAY	58031R1S	1x 31W LED	3340 lm	0.80	35 W	28
A2	Thorlux	STARBEAM LED ROADWAY	68062R1S	1x 62W LED	9640 lm	0.80	71 W	4
B1	THORLUX	Passway 11W - Pathway Distribution - 1100mm Road Mounted - 4000K	PW119113	1x Passway 11W Pathway	780 lm	0.80	14 W	7

[illegible]

P01	21/10/20	Issued For Information	ISa	OMS	
Rev.	Date	Description	By	Chk'd	App'd
Drawing Suitability				Status	

Drawing Suitability	<b>INFORMATION</b>	Status	<b>S2</b>
---------------------	--------------------	--------	-----------

 The HUR

 **SNC • LAVALIN**

**ATKINS**

Member of the SNC-Lavalin Group

The HUB  
500 Park Avenue  
Almondsbury  
Bristol  
BS32 4RZ

Tel: +44 1454 662000  
[www.atkinsglobal.com](http://www.atkinsglobal.com)

© SNC-Lavalin (2019)

Client	
--------	--



**VANTAGE**  
DATA CENTERS

 DATA CENTERS

Project Title	DATA CENTRE THREE
---------------	-------------------

DATA CENTRE THREE

100 JOURNAL OF MANAGEMENT INQUIRY / December 2005

Electrical Engineering  
Services Sitewide External

### Services Sitewide External Lighting Layout

Scale	Designed	Drawn	Checked	Authorised
As indicated	CSa	ISa	OMS	JO

Original Size A0	Date 21/10/20	Date 21/10/20	Date 21/10/20	Date 21/10/20
---------------------	------------------	------------------	------------------	------------------

Drawing Number	Revision

DC3-ATK-ZZ-ZZ-DR-EE-641001	P01
----------------------------	-----

CLASSIFICATION - CONTAINS BASELINE INFORMATION